

PROPERTY LINE



11.8M

38 WATER SERVICE, SEE CIVIL DRAWINGS FOR CONT

150 SANITARY SEWER SERVICE, SEE CIVIL DRAWINGS FOR CONT

FOUNDATION PLAN - PLUMBING

SCALE: 1:50

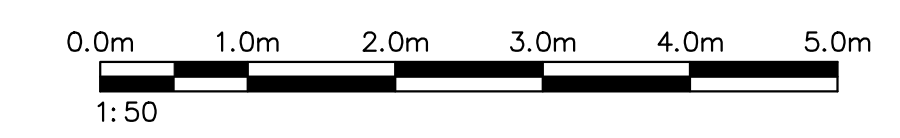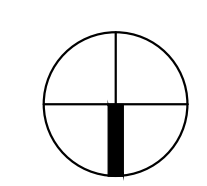

No.	Description	Date
1	ISSUED TO PROJECT ARCHITECT	15.10.30

- REVISIONS**
1. THIS DRAWING IS THE PROPERTY OF A&W FOOD SERVICES OF CANADA INC., & MAY NOT BE USED IN WHOLE OR IN PART FOR ANY PROJECT OTHER THAN THAT DESIGNATED HEREON.
 2. DO NOT SCALE DRAWINGS - WRITTEN DIMENSIONS TAKE PRECEDENCE.
 3. CONTRACTOR TO VERIFY JOB SITE DIMENSIONS & CONDITIONS, REPORT ANY & ALL DISCREPANCIES TO THE OWNER & A&W IMMEDIATELY BEFORE PROCEEDING WITH WORK.
 4. ALL WORK TO CONFORM TO THE LATEST LOCAL BUILDING CODES, BY-LAWS, & NFPA REQUIREMENTS, IN ADDITION TO OTHER REGULATIONS HAVING JURISDICTION.

Consultant

Association of Professional Engineers & Geoscientists of Saskatchewan
CERTIFICATE OF AUTHORIZATION
Zbaraschuk Engineering Company
 Number 29003

Permission to Consult held by:
 Discipline: MECH Sk. Reg. No. 16600 Signature: [Signature]

ZBARASCHUK ENGINEERING CO.
 DENNIS W. ZBARASCHUK, P. ENG
 RR4 SITE 12 BOX 4
 PRINCE ALBERT, SK S6V 5R2
 (306) 929-4923 dwzbor@sosktel.net

PRAKASH
PRAKASH CONSULTING LTD
STRUCTURAL ENGINEERS

#4 - 210 15TH STREET EAST
 PRINCE ALBERT, SK S6V 1G2
 T 306 922 2101 F 306 763 0212

RNF
VENTURES LTD.

811 CENTRAL AVENUE PH: (306) 763-3700
 PRINCE ALBERT, SK S6V 4V2 FX: (306) 763-4700

A&W
A&W FOOD SERVICES OF CANADA INC.

Project:
A&W RESTAURANT
"2015 GFMGF CONCEPT DESIGN"
 11401 RAILWAY AVE,
 NORTH BATTLEFORD, SK

Title: **FOUNDATION PLAN - PLUMBING**

Date Created	February 2016	Prototype Version	2178L (2015 V1.1)
Project Number	14064	Page Number	
Drawn By	RMS	Scale	AS NOTED
Consultant			M1.1