

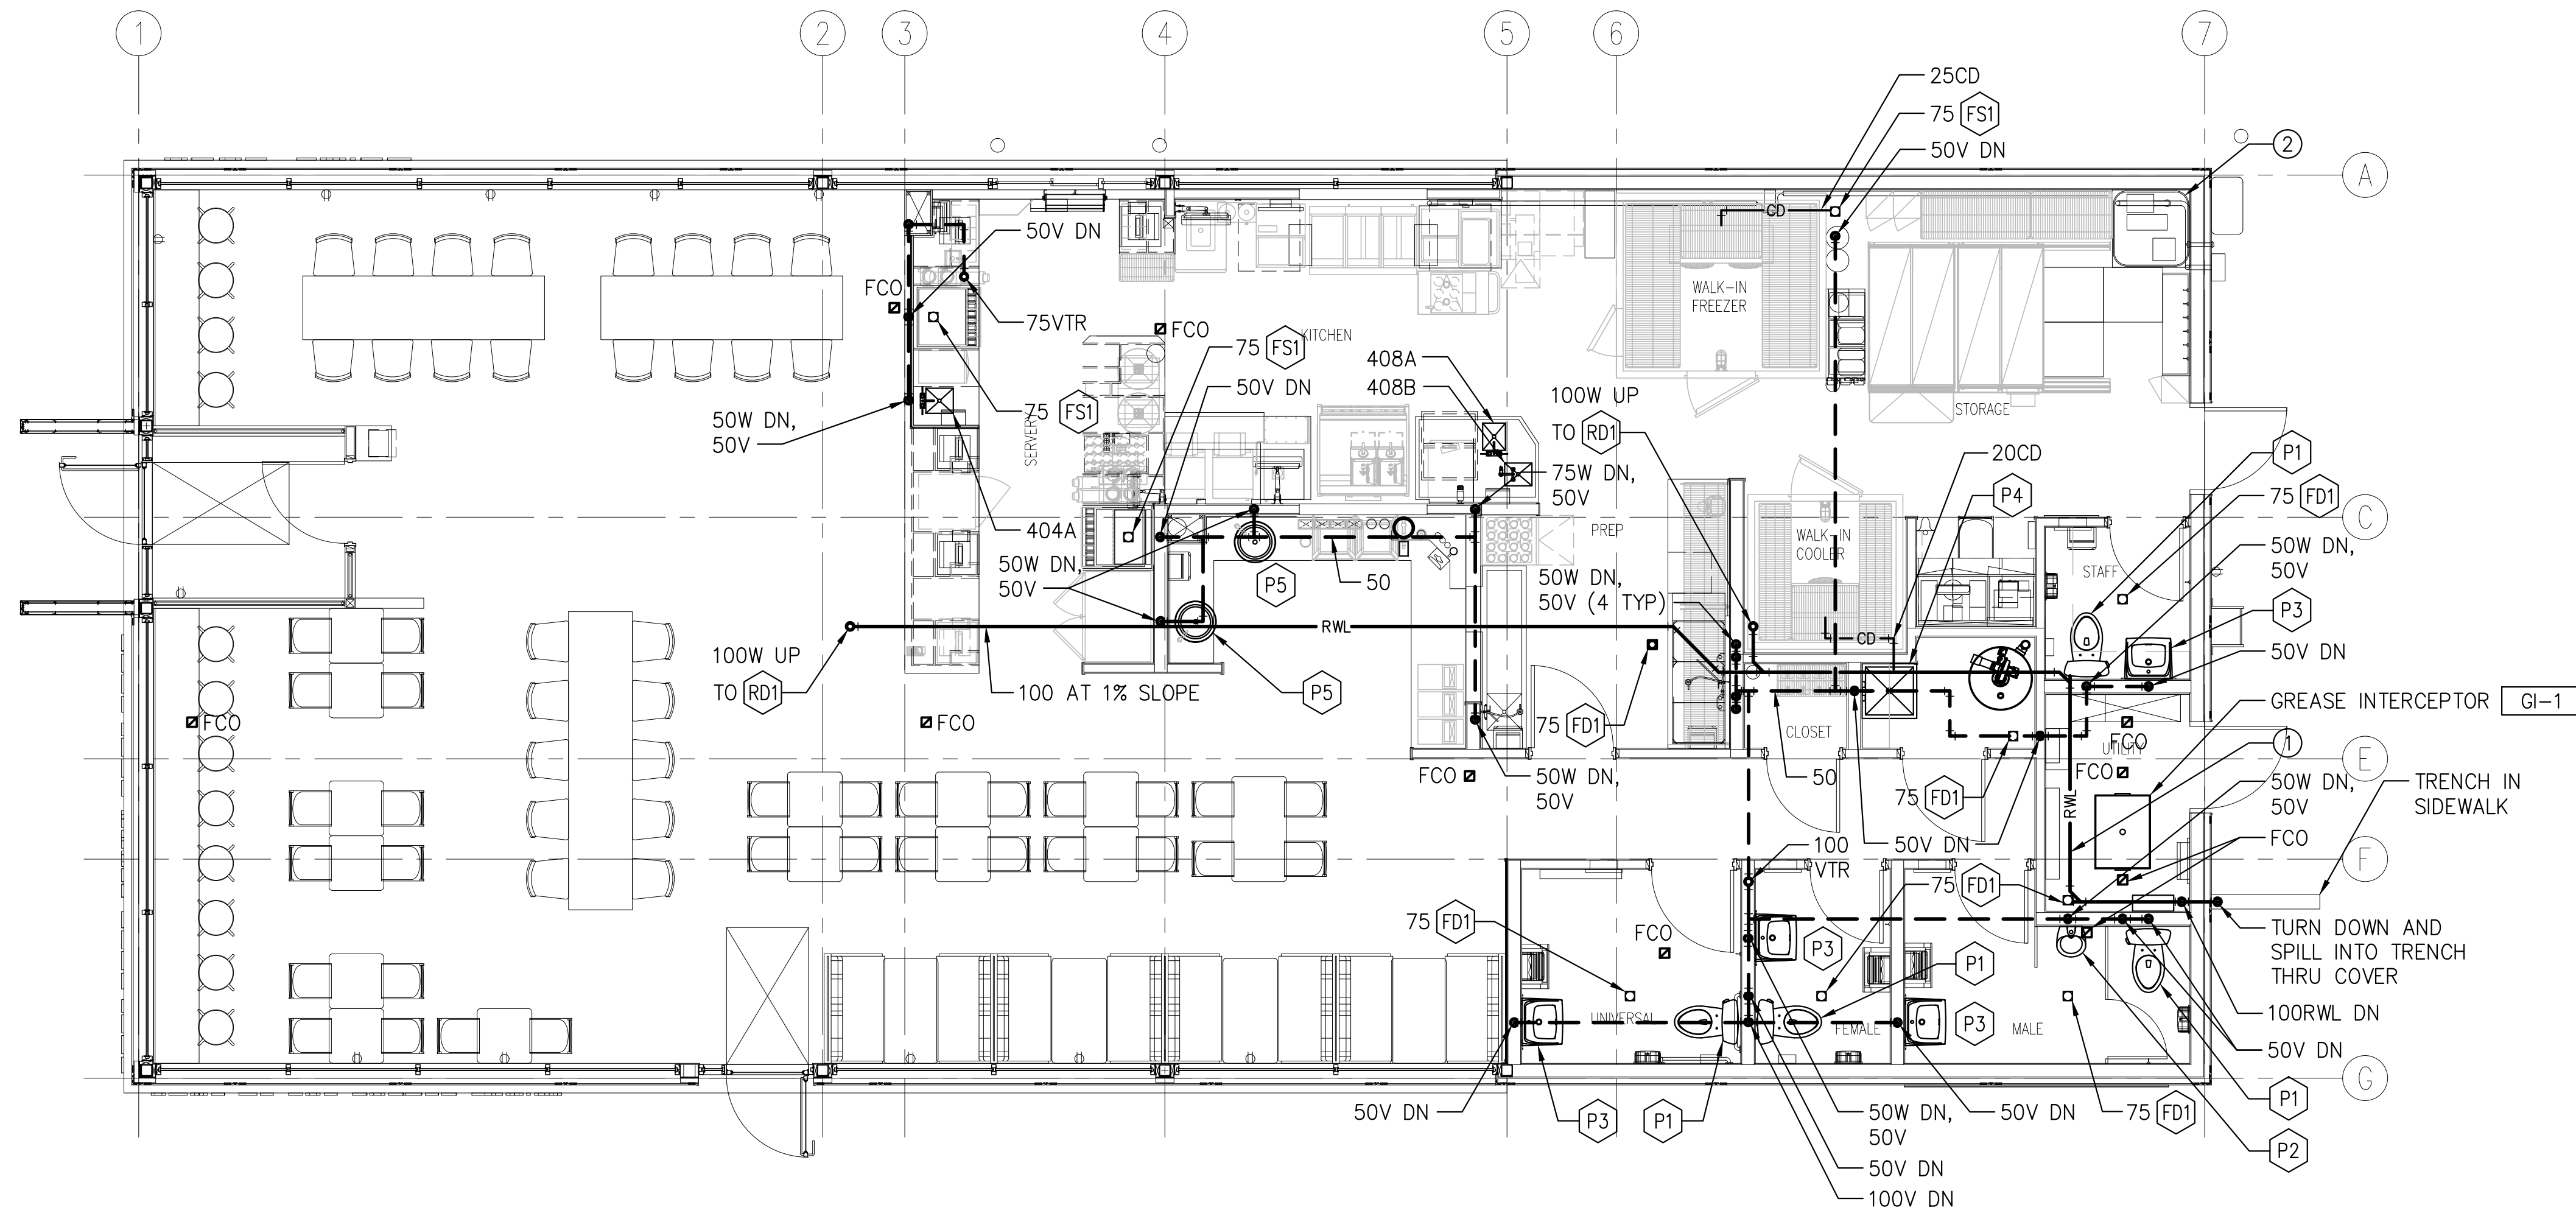


KEY NOTES:

- ① INSULATE RAINWATER LEADER AND EXPOSED CEILING AREAS. COVER INSULATION AND FITTINGS WITH PVC JACKET AND PREFORMED FITTING COVERS.
- ② PROVIDE PIPING TO "SANIMAX" GREASE TANK SUPPLY BY OWNER, SEE A10.0 AND DETAIL 5 ON M3.2.

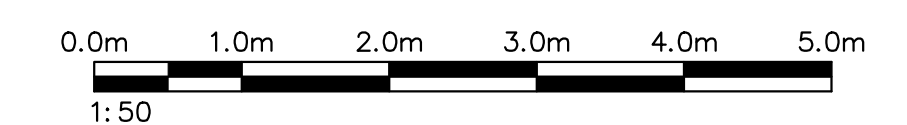

FLOOR PLAN - RAINWATER AND VENT PIPING
SCALE: 1:50

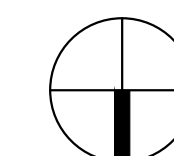

No.	Description	Date
1	ISSUED TO PROJECT ARCHITECT	15.10.30

- REVISIONS**
1. THIS DRAWING IS THE PROPERTY OF A&W FOOD SERVICES OF CANADA INC., & MAY NOT BE USED IN WHOLE OR IN PART FOR ANY PROJECT OTHER THAN THAT DESIGNATED HEREON.
 2. DO NOT SCALE DRAWINGS - WRITTEN DIMENSIONS TAKE PRECEDENCE.
 3. CONTRACTOR TO VERIFY JOB SITE DIMENSIONS & CONDITIONS, REPORT ANY & ALL DISCREPANCIES TO THE OWNER & A&W IMMEDIATELY BEFORE PROCEEDING WITH WORK.
 4. ALL WORK TO CONFORM TO THE LATEST LOCAL BUILDING CODES, BY-LAWS, & NFPA REQUIREMENTS, IN ADDITION TO OTHER REGULATIONS HAVING JURISDICTION.

Consultant

Association of Professional Engineers & Geoscientists of Saskatchewan
CERTIFICATE OF AUTHORIZATION
Zbaraschuk Engineering Company
 Number 2003

Permission to Consult held by:
 Discipline: MECH Sk. Reg. No. 16600 Signature: [Signature]

ZBARASCHUK ENGINEERING CO.
 DENNIS W. ZBARASCHUK, P. ENG
 RR4 SITE 12 BOX 4
 PRINCE ALBERT, SK S6V 5R2
 (306) 929-4923 dwzbor@sasktel.net

PRAKASH
PRAKASH CONSULTING LTD
STRUCTURAL ENGINEERS

#4 - 210 15TH STREET EAST
 PRINCE ALBERT, SK S6V 1G2
 T 306 922 2101 F 306 763 0212

RNF
VENTURES LTD.

811 CENTRAL AVENUE PH: (306) 763-3700
 PRINCE ALBERT, SK FX: (306) 763-4700
 S6V 4Z2

A&W FOOD SERVICES OF CANADA INC.

Project:
A&W RESTAURANT
"2015 GFMGF CONCEPT DESIGN"
 11401 RAILWAY AVE,
 NORTH BATTLEFORD, SK

Title:
FLOOR PLAN - RAINWATER
AND VENT PIPING

Date Created	February 2016	Prototype Version	2178L (2015 V1.1)
Project Number	14064	Page Number	
Drawn By	RMS	Scale	AS NOTED
Consultant		Page Number	
			M1.2