




KEY NOTES:

- ① COLD WATER DOWN TO WATER FILTER UNIT.
- ② WATER FILTER UNIT.
- ③ TO REDUCED PRESSURE BACKFLOW ASSEMBLY, SEE M3.1.
- ④ TO REDUCED PRESSURE BACKFLOW ASSEMBLY,
- ⑤ PROVIDE ROUGH-IN 15mm FILTERED WATER TO FUTURE MILK SHAKE MACHINE.
- ⑥ PROVIDE 15mm FILTERED WATER TO COFFEE MACHINE.
- ⑦ PROVIDE SHUT-OFF VALVE AND SOLENOID VALVE FOR GAS SERVICE TO KITCHEN EQUIPMENT.
- ⑧ 32 GAS UP TO MAU-1.
- ⑨ 32 GAS UP TO AC-1.
- ⑩ 32 GAS DOWN TO FRYERS.
- ⑪ 32 GAS DOWN TO GRILLE.
- ⑫ 20HB, COLD WATER AND HOT WATER, PROVIDE VACUUM BREAKERS. 1,200 ABOVE FINISH FLOOR.
- ⑬ 150 PVC CONDUIT UP 100mm INTO CEILING SPACE AND ELBOW OUT OF WALL 150mm ABOVE FINISH FLOOR.
- ⑭ RUN PIPING IN WALL 400mm ABOVE FINISH FLOOR.

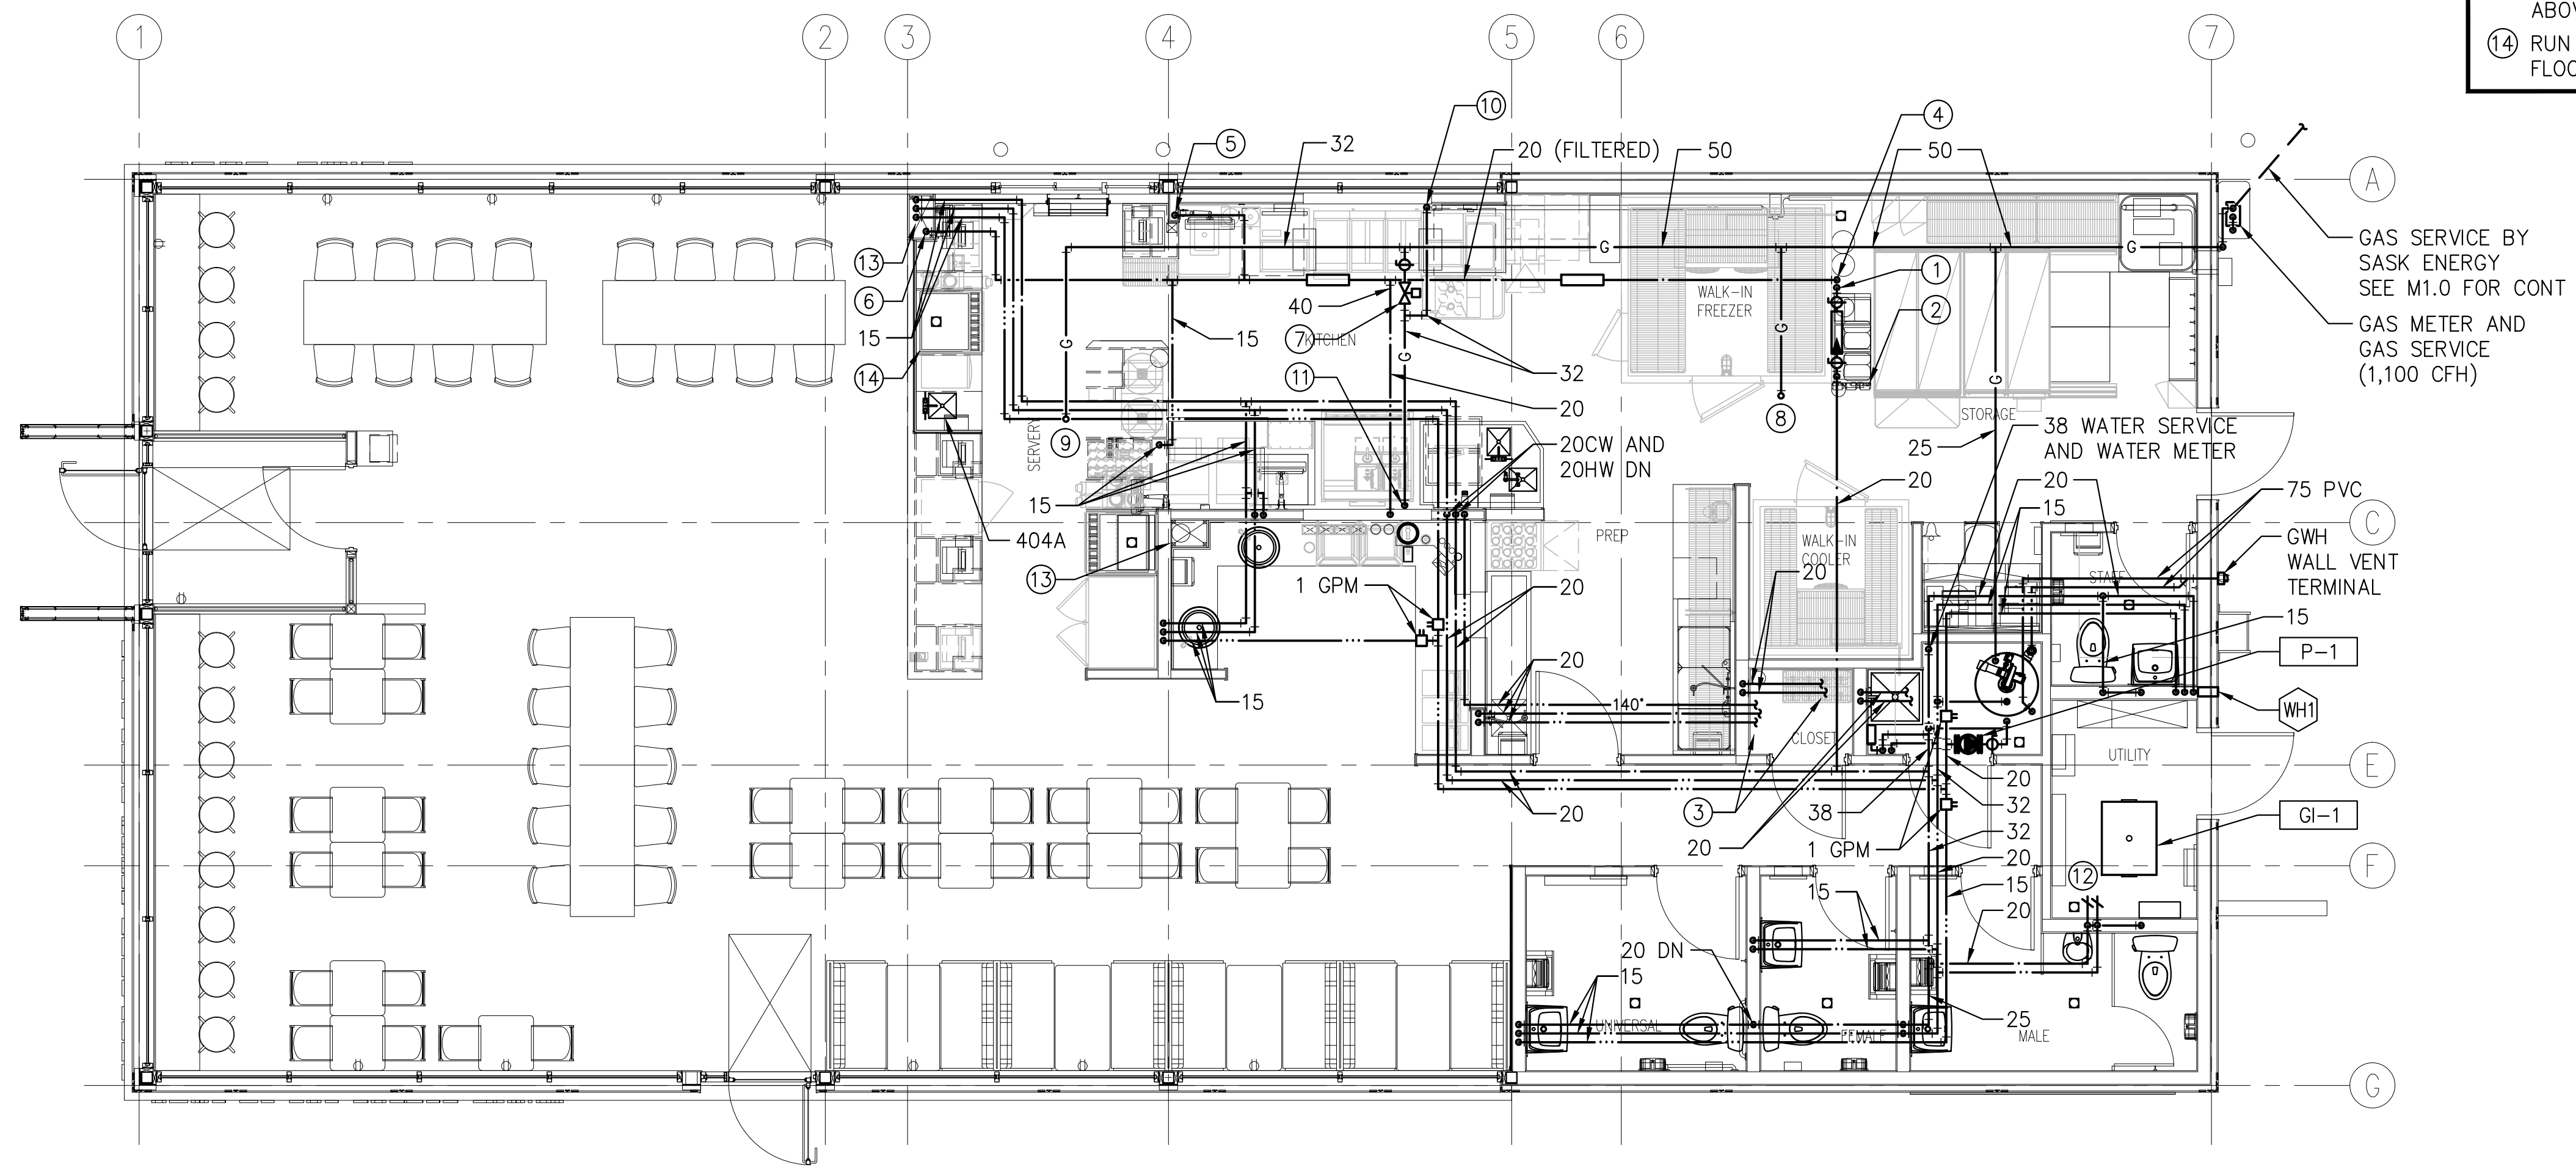

FLOOR PLAN - DOMESTIC WATER AND GAS PIPING

SCALE: 1:50

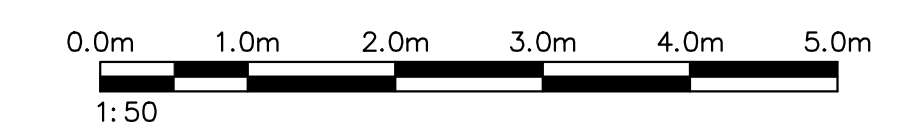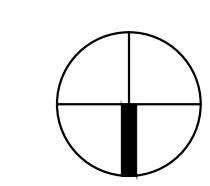

No.	Description	Date
1	ISSUED TO PROJECT ARCHITECT	15.10.30

- REVISIONS**
1. THIS DRAWING IS THE PROPERTY OF A&W FOOD SERVICES OF CANADA INC., & MAY NOT BE USED IN WHOLE OR IN PART FOR ANY PROJECT OTHER THAN THAT DESIGNATED HEREON.
 2. DO NOT SCALE DRAWINGS - WRITTEN DIMENSIONS TAKE PRECEDENCE.
 3. CONTRACTOR TO VERIFY JOB SITE DIMENSIONS & CONDITIONS, REPORT ANY & ALL DISCREPANCIES TO THE OWNER & A&W IMMEDIATELY BEFORE PROCEEDING WITH WORK.
 4. ALL WORK TO CONFORM TO THE LATEST LOCAL BUILDING CODES, BY-LAWS, & NFPA REQUIREMENTS, IN ADDITION TO OTHER REGULATIONS HAVING JURISDICTION.

Consultant

Association of Professional Engineers & Geoscientists of Saskatchewan
CERTIFICATE OF AUTHORIZATION
Zbaraschuk Engineering Company
 Number 29003

Permission to Consult held by:
 Discipline: Mech Sk. Reg. No. 16000 Signature: [Signature]

ZBARASCHUK ENGINEERING CO.
 DENNIS W. ZBARASCHUK, P. ENG
 RR4 SITE 12 BOX 4
 PRINCE ALBERT, SK S6V 5R2
 (306) 929-4923 dwzbor@sosktel.net

PRAKASH
PRAKASH CONSULTING LTD
STRUCTURAL ENGINEERS

#4 - 210 15TH STREET EAST
 PRINCE ALBERT, SK S6V 1G2
 T 306 922 2101 F 306 763 0212

RNF
VENTURES LTD.

811 CENTRAL AVENUE PH: (306) 763-3700
 PRINCE ALBERT, SK FX: (306) 763-4700
 S6V 4Z2

A&W

A&W FOOD SERVICES OF CANADA INC.

Project:
A&W RESTAURANT
"2015 GFMGF CONCEPT DESIGN"
 11401 RAILWAY AVE,
 NORTH BATTLEFORD, SK

Title:
FLOOR PLAN - DOMESTIC
WATER AND GAS PIPING

Date Created	February 2016	Prototype Version	2178L (2015 V1.1)
Project Number	14064	Page Number	
Drawn By	RMS	Scale	AS NOTED
Consultant			
			M1.3