

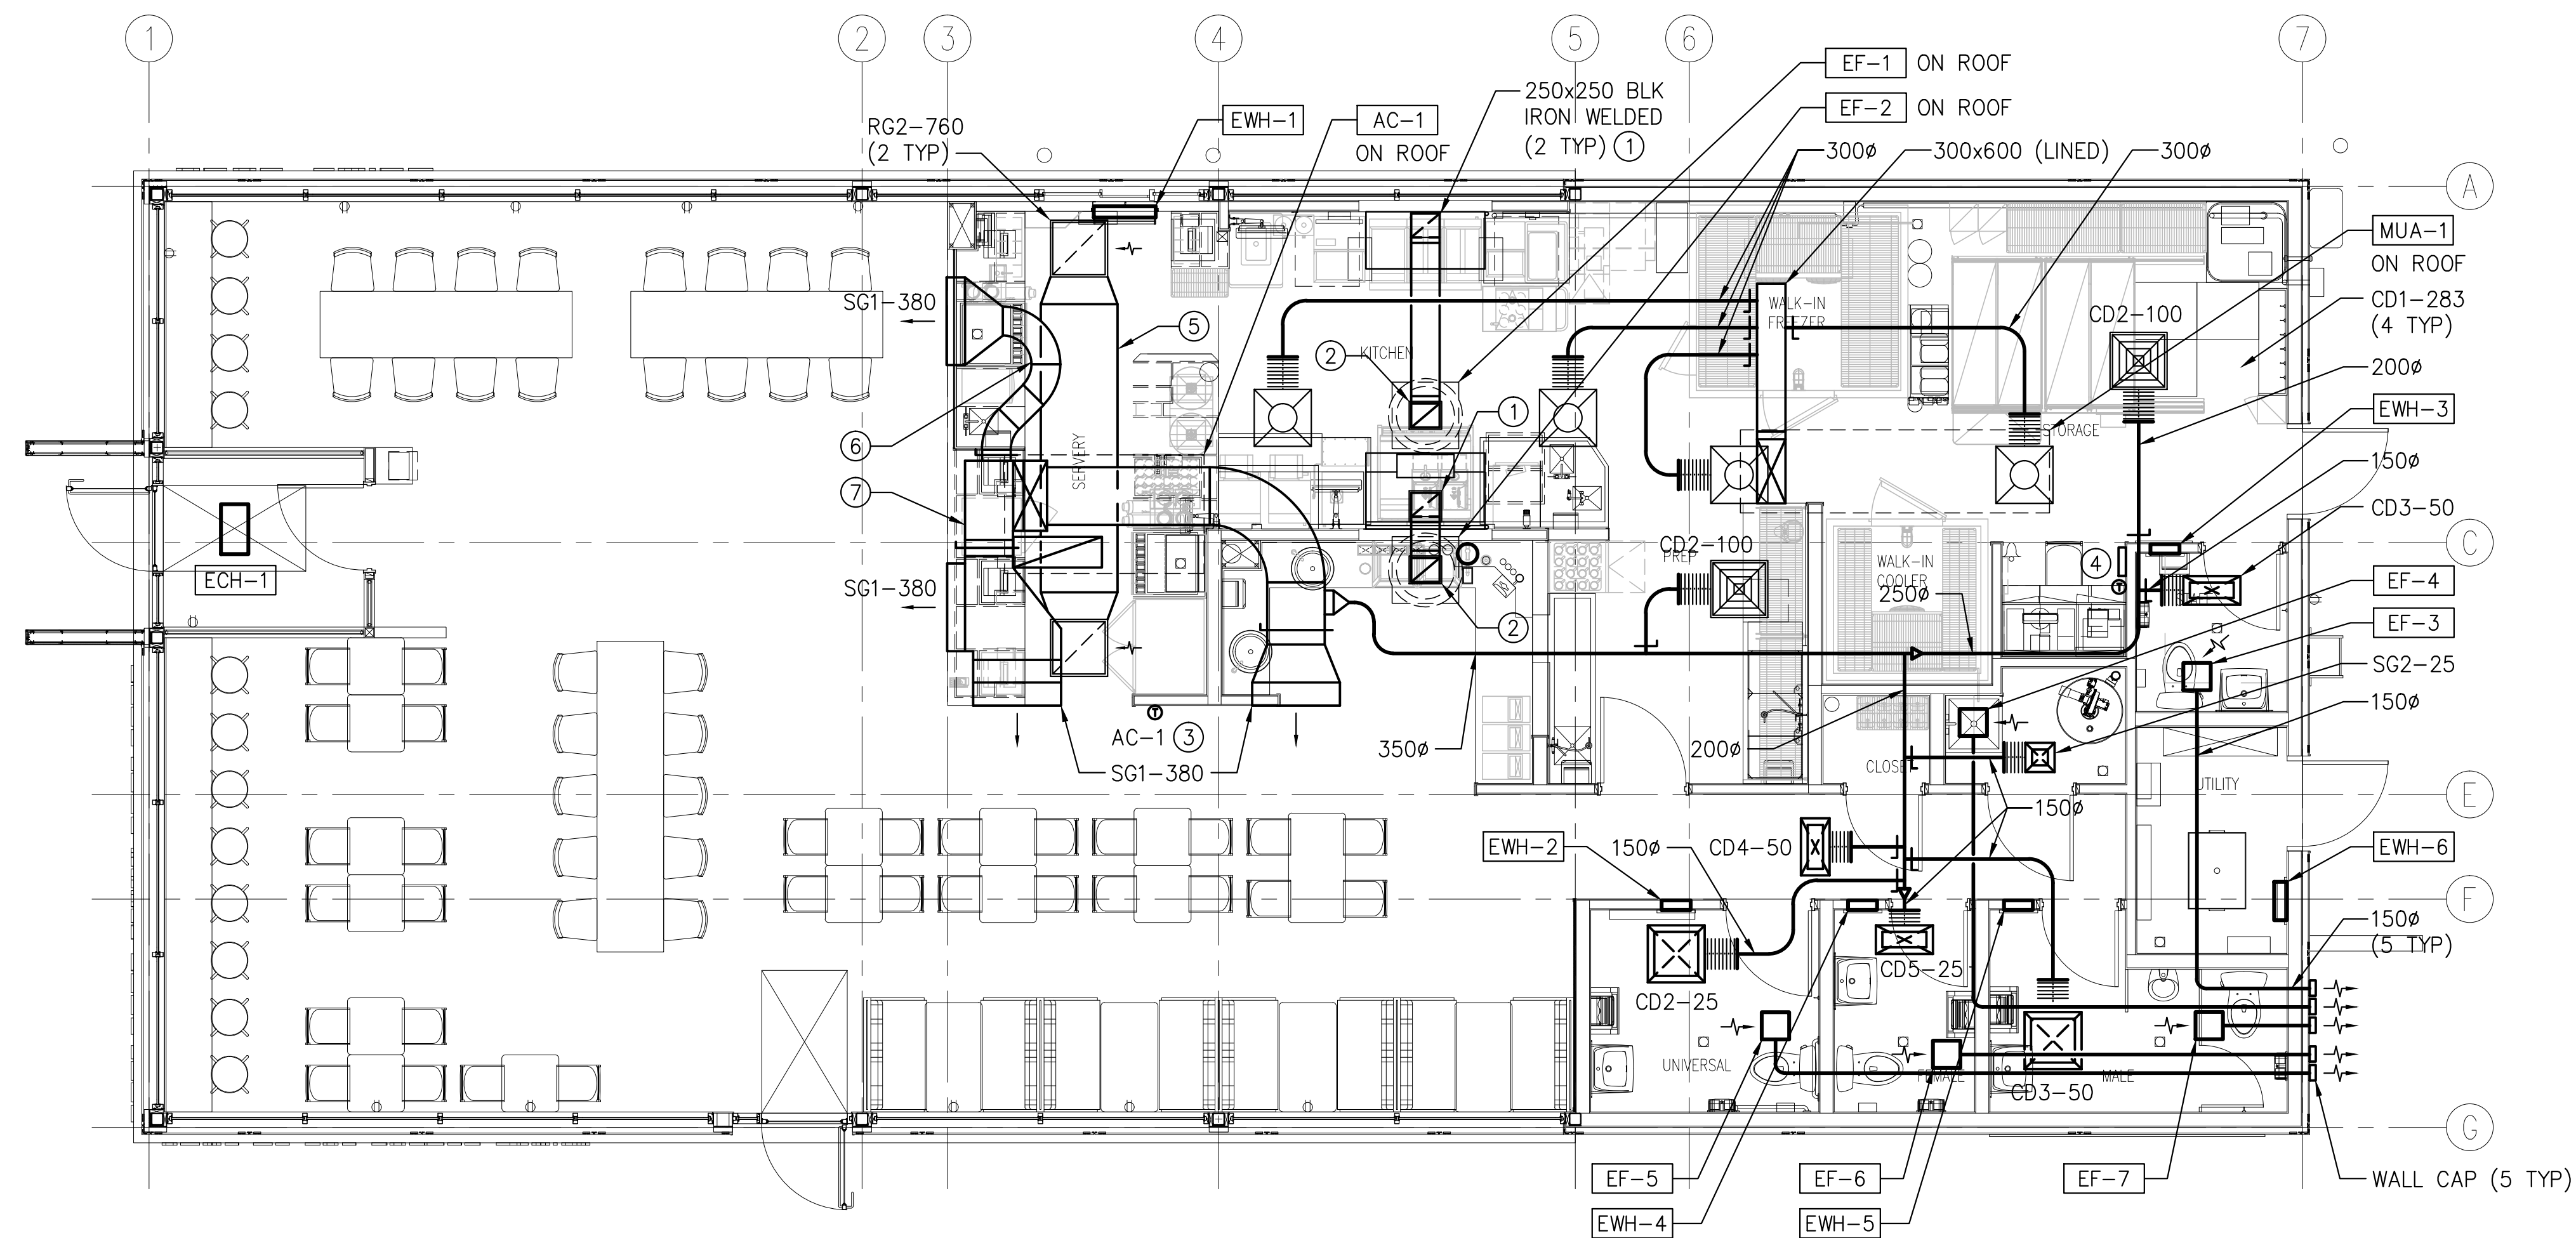


KEY NOTES:

- ① PROVIDE STAINLESS STEEL ENCLOSURE (3 SIDES) FROM TOP OF EXHAUST HOOD UP INTO CEILING SPACE.
- ② PROVIDE 2 LAYERS OF 3M FIRE BARRIER DUCT WRAP 615+ AROUND DUCT RISER TO FAN.
- ③ PROVIDE PLASTIC GUARD FOR THERMOSTAT.
- ④ CONTROL PANEL AND THERMOSTAT FOR MAU-1, SEE DRAWING A-9.0.
- ⑤ 600x300 LINED.
- ⑥ 350x300 LINED.
- ⑦ 400 DEEP SA PLENUM LINED.

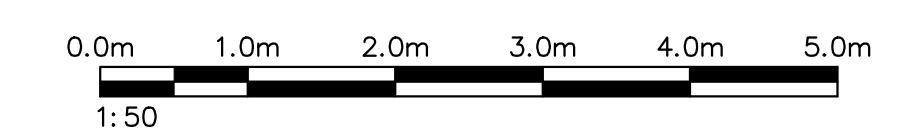

FLOOR PLAN - HVAC
SCALE: 1:50

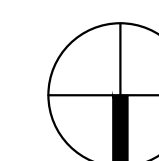

No.	Description	Date
1	ISSUED TO PROJECT ARCHITECT	15.10.20

- REVISIONS**
1. THIS DRAWING IS THE PROPERTY OF A&W FOOD SERVICES OF CANADA INC., & MAY NOT BE USED IN WHOLE OR IN PART FOR ANY PROJECT OTHER THAN THAT DESIGNATED HEREON.
 2. DO NOT SCALE DRAWINGS - WRITTEN DIMENSIONS TAKE PRECEDENCE.
 3. CONTRACTOR TO VERIFY JOB SITE DIMENSIONS & CONDITIONS, REPORT ANY & ALL DISCREPANCIES TO THE OWNER & A&W IMMEDIATELY BEFORE PROCEEDING WITH WORK.
 4. ALL WORK TO CONFORM TO THE LATEST LOCAL BUILDING CODES, BY-LAWS, & NFPA REQUIREMENTS, IN ADDITION TO OTHER REGULATIONS HAVING JURISDICTION.

Consultant

Association of Professional Engineers & Geoscientists of Saskatchewan
CERTIFICATE OF AUTHORIZATION
Zbaraschuk Engineering Company
 Number 2003

Permission to Consult held by:
 Discipline: MECH Sk. Reg. No. 16600 Signature: [Signature]

ZBARASCHUK ENGINEERING CO.
 DENNIS W. ZBARASCHUK, P. ENG
 RR4 SITE 12 BOX 4
 PRINCE ALBERT, SK S6V 5R2
 (306) 929-4923 dzbar@zositel.net

PRAKASH
PRAKASH CONSULTING LTD
STRUCTURAL ENGINEERS

#4 - 210 15TH STREET EAST
 PRINCE ALBERT, SK S6V 1G2
 T 306 922 2101 F 306 763 0212

RNF
VENTURES LTD.

811 CENTRAL AVENUE PH: (306) 763-3700
 PRINCE ALBERT, SK FX: (306) 763-4700
 S6V 4V2

A&W FOOD SERVICES OF CANADA INC.

Project:
A&W RESTAURANT
"2015 GFMGF CONCEPT DESIGN"
 11401 RAILWAY AVE,
 NORTH BATTLEFORD, SK
 Title: **FLOOR PLAN - HVAC**

File Name	Date Created	Prototype Version
	FEBRUARY 2016	2178L (2015 V1.1)
Project Number	14064	Page Number
AW	Consultant	M2.1
Drawn By	RMS	Scale
		AS NOTED