




MEADOW LAKE PROVINCIAL PARK SANDY BEACH SERVICE CENTRE REPLACEMENT

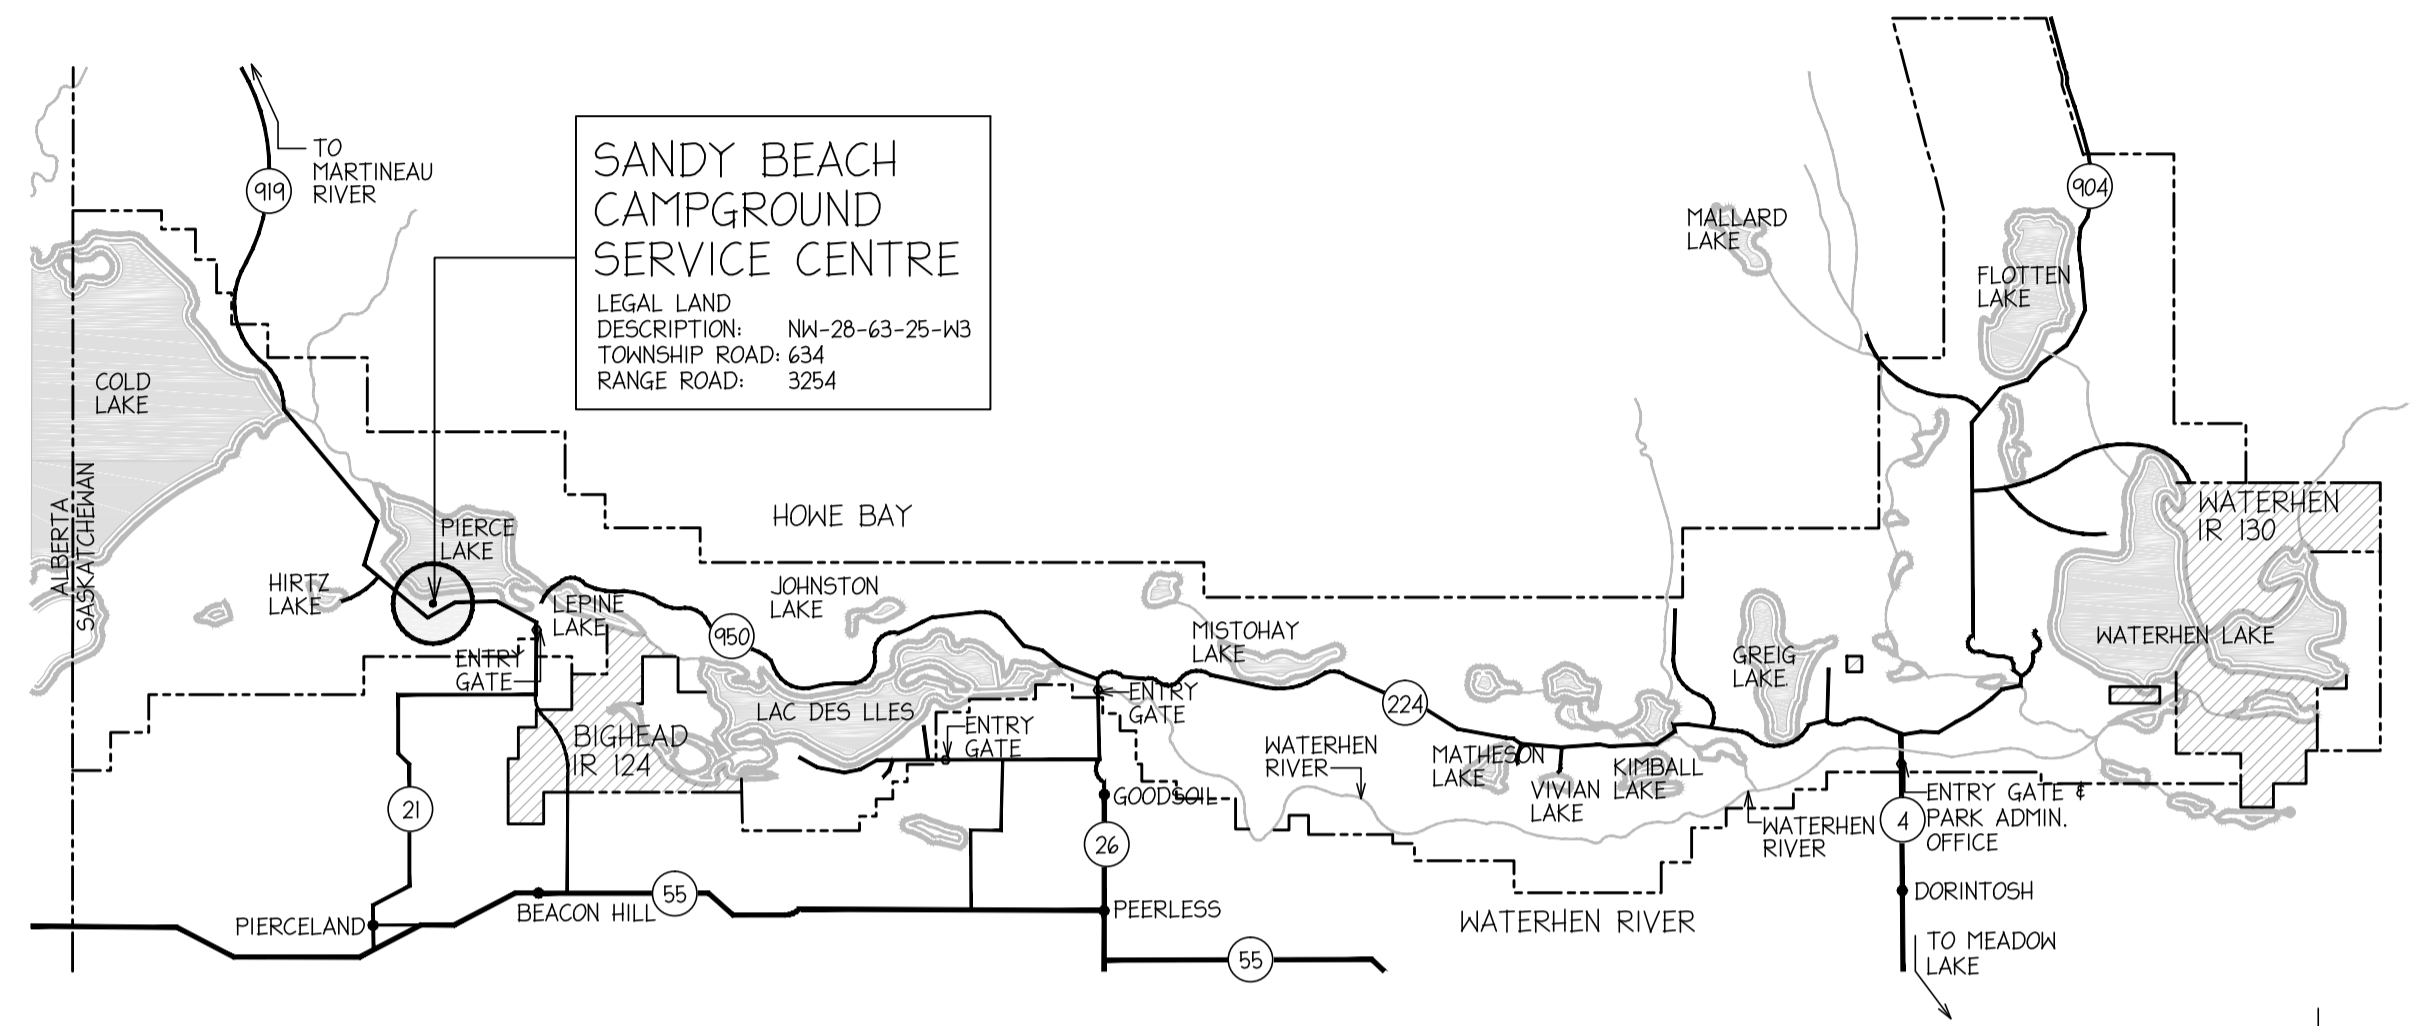

ABBREVIATION LEGEND			
A.F.F. ACC. ALUM. ANOD. APPROX.	ABOVE FINISH FLOOR ACCESSIBLE ALUMINIUM ANODIZED APPROXIMATE	LUM.	LUMINAIRE (ELEC.)
B.U. B.S. BLK. BKR. BTW BLKG. BLDG.	BUILT-UP BULLNOSE BOTH SIDES BLOCK BREAKER BETWEEN BLOCKING BUILDING	MECH. MET. MTD.	MECHANICAL METAL MOUNTED
C/N C.B. C.J. C.T. CEIL. CLR. COL. CONT. CONC. CNST.	COMPLETE WITH CATCH BASIN CONTROL JOINT CERAMIC TILE CEILING CLEAR COLUMN CONTINUOUS CONCRETE CONSTRUCTION	N.D. N.I.C.	NAPKIN DISPOSAL NOT IN CONTRACT
DN. DET. DIAM. DWG.	DOWN DETAIL DIAMETER DRAWING	O/C OVHD.	ON CENTRE OVERHEAD
EL./ELEV. ELEC. EXP. EXT.	ELEVATION ELECTRICAL EXPOSED EXTERIOR	P-LAM P-T. P-S.F. PTD. PLYWD. PWF PREFIN.	PLASTIC LAMINATE PRESSURE TREATED PRESSURE TREATED PAINTED PLYWOOD PRESSURE TREATED PREFINISHED
F.E. F.D. FIN. FLUOR. FDN.	FIRE EXTINGUISHER FLOOR DRAIN FINISHED FLUORESCENT FOUNDATION	R.O. R.H. R.W.L. REF. RECEP. REIN. REFLEC. REQ'D.	ROUGH OPENING ROBE HOOK RAIN WATER LEADER REFER RECEPTACLE REINFORCED REFLECTED REQUIRED
F.E. G.I.S. GA. GALV. GFI	FIRE EXTINGUISHER GOOD ONE SIDE GAUGE GALVANIZED GROUND FAULT INTERRUPT.	S.H. S.S. SCHD. SIM. SPEC. STL. STRUCT. SUSP.	SHOWER HEAD STAINLESS STEEL SCHEDULE SIMILAR SPECIFICATION STEEL STRUCTURAL SUSPENDED
H.D. H.M. H.S.S. HORIZ.	HAND DRIER (ELEC.) HOLLOW METAL HOLLOW STRUCT. SECTION HORIZONTAL	T/O T.J. T.P.H. TYP. TEMP.	TOP OF TOOLED JOINT TOILET PAPER HOLDER TYPICAL TEMPERED
INT. INSUL.	INTERIOR INSULATION	U/S U/G	UNDER SIDE UNDERGROUND
		W/ W/S W/C W.R. W.D. W.P.	WITH WATER HEATER WATER SOFTENER WATER CLOSET WASHROOM WOOD WATER PROOF

ISSUED FOR TENDER/CONSTRUCTION 19-04-17
ISSUED FOR FINAL REVIEW 29-04-16
ISSUED FOR REVIEW 31-03-16
ISSUED FOR REVIEW 75% 28-03-16
ISSUED FOR REVIEW 50% 11-03-16
ISSUED FOR OWNER REVIEW 12-02-16

NOTES:

- THIS PLAN WAS PREPARED FOR THE GOVERNMENT'S INTERNAL PURPOSES ONLY. THE GOVERNMENT DOES NOT WARRANT THAT THIS PLAN IS APPROPRIATE FOR ANY OTHER PURPOSE OR LOCATION. NEITHER THE MINISTER NOR THE GOVERNMENT ACCEPTS ANY RESPONSIBILITY FOR ANY LOSSES OR DAMAGES ARISING FROM ANYONE USING THIS PLAN. THE USER MUST ENSURE THAT ANYTHING BUILT FROM THIS PLAN IS ADEQUATE AND SAFE FOR THE USER'S PARTICULAR SITE CONDITIONS. THIS SHALL INCLUDE, BUT SHALL NOT BE LIMITED TO, ALL FOUNDATION, STRUCTURAL, SAFETY, AND ANY OTHER APPLICABLE REQUIREMENTS.
- THE USER SHALL ALSO ENSURE THAT THIS PLAN WILL SUIT THE PARTICULAR SITE AND COMPLY WITH ANY OTHER RELEVANT FEDERAL, PROVINCIAL OR MUNICIPAL REGULATIONS AND CODES WHICH APPLY AT THE USER'S SITE.
- THE LOCATION OF THE UNDERGROUND SERVICES AS SHOWN IS APPROXIMATE ONLY. OTHER UNKNOWN SERVICES MAY EXIST IN THE VICINITY. PLEASE CHECK WITH THE APPROPRIATE UTILITY COMPANY AND THE PARK/SITE MAINTENANCE SUPERVISOR OR REPRESENTATIVE.
- IT IS THE RESPONSIBILITY OF ANYONE USING THIS PLAN FOR DESIGN PURPOSES TO VERIFY ALL INFORMATION SHOWN ON THIS PLAN. IT IS THE USER'S RESPONSIBILITY TO IDENTIFY ANY UTILITY INFRASTRUCTURE.

DRAWING SCHEDULE

ARCHITECTURAL

- A.000 TITLE PAGE
- A.100 EXISTING AND DEMOLITION SITE PLAN
- A.101 NEW SITE PLAN AND NEW & EXISTING GRADING
- A.102 MAIN FLOOR PLAN
- A.103 REFLECTED CEILING PLAN AND SCHEDULES
- A.104 ROOF PLAN AND END GABLE DETAILS
- A.200 BUILDING ELEVATIONS
- A.300 BUILDING SECTIONS AND END GABLE DETAIL
- A.400 SHOWER AREA FLOOR PLAN INTERIOR ELEVATIONS & DETAILS
- A.401 INTERIOR ELEVATIONS
- A.500 WALL SECTIONS AND DETAILS
- A.600 DETAILS
- A.601 DETAILS

STRUCTURAL

- S.1 MAIN FLOOR SLAB PLAN & GENERAL NOTES
- S.2 ROOF FRAMING PLAN & TYPICAL DETAILS
- S.3 CONCRETE BLOCK WALL ELEVATIONS & DETAILS

MECHANICAL

- M.1 MECHANICAL SITE SERVICING PLAN
- M.2A WATER SUPPLY PLAN
- M.2B SEWER AND GAS PLAN
- M.3 H.V.A.C. PLAN
- M.4 MECHANICAL SPECIFICATIONS AND DETAILS

ELECTRICAL

- E.1 EXISTING AND NEW SITE PLANS ELECTRICAL LAYOUT & DETAILS
- E.2 MAIN FLOOR PLAN ELECTRICAL LAYOUT
- E.3 ELECTRICAL SPECIFICATIONS & DETAILS

MAURICE SOULODRE
ARCHITECT LTD
1815C LORNE AVE
SASKATOON, SK S7H 1Y5
TEL (306) 955-0333
FAX (306) 955-0549
EMAIL soularch@sasktel.net

PROJECT
SERVICE CENTRE REPLACEMENT
MEADOW LAKE
PROVINCIAL PARK

**SANDY BEACH
CAMPGROUND**

MINISTRY OF PARKS, CULTURE AND SPORT
PARKS SERVICE BRANCH
2nd FLOOR 3211 ALBERT STREET
REGINA, SASKATCHEWAN
S4S 5W6

DRAWING
TITLE SHEET

SCALE: 1:200
PLOTTED: 19-04-2017
FILE: 3556C
DATE: APRIL 2017
DESIGN: MS
DRAWN: DU

DRAWING NO. **A.000**

Saskatchewan Ministry of Parks, Culture and Sport		MEADOW LAKE PROVINCIAL PARK SANDY BEACH CAMPGROUND	
SERVICE CENTRE REPLACEMENT TITLE SHEET		PLAN NO. SHEET 1 OF 24 1008-30-F22-15C	
RECOMMENDED DATE (Month/Day/Year) 04/21/2017	REVIEWED DATE (Month/Day/Year) 04/21/2017	ORIGINATING BRANCH FACILITIES DESIGNED DATE MAY, 2016	
DIRECTOR		BRANCH PARKS SERVICE DATE APRIL, 2017	
DIRECTOR		DU DATE APRIL, 2017	
APPROVED 04/21/17		PARKS SERVICE DRAWING CHECKED	
		SCALE GLOBAL SCALE GLOBAL 1:200	

